

LEGEND

DESCRIPTION	ABBREVIATION
CORRUGATED METAL PIPE	CMP
REINFORCED CONCRETE PIPE	RCP
IRON REBAR SET	IRS
IRON REBAR FOUND	IRF
INVERT	INV
INVERT ELEVATION	IE
IRON PIN SET	IPS
DUCTILE IRON PIPE	DIP
UNDERGROUND POWER	UGP
FINISHED FLOOR ELEVATION	FFE
RIGHT OF WAY	R/W
BOLLARD	BOL
CLEANOUT	C.O.
IRRIGATION CONTROL VALVE	ICV
CONCRETE MONUMENT FOUND	CMF
AIR CONDITIONING UNIT	A/C

DESCRIPTION	EXISTING
CONTOUR	
SPOT ELEVATION	
ASPHALT	
CONCRETE	
UTILITY POLE	
OVERHEAD UTILITY LINE	
UNDERGROUND FIBER OPTIC LINE	
TELEPHONE PEDESTAL	
GUY ANCHOR	
WATER LINE	
SANITARY SEWER LINE	
STORM PIPE	
LIMITS OF DISTURBANCE	
FIRE HYDRANT	
GAS LINE	
SANITARY SEWER MANHOLE	
CURB AND GUTTER	
WATER METER	
CHAIN LINK FENCE	
WATER VALVE	

NOTE:
1. UNDERGROUND UTILITIES ON THE SITE HAVE NOT BEEN LOCATED.


82 Parking Spots Needed. Walkway Included.

Drive way Alteration

Perimeter

Parking

Walkway

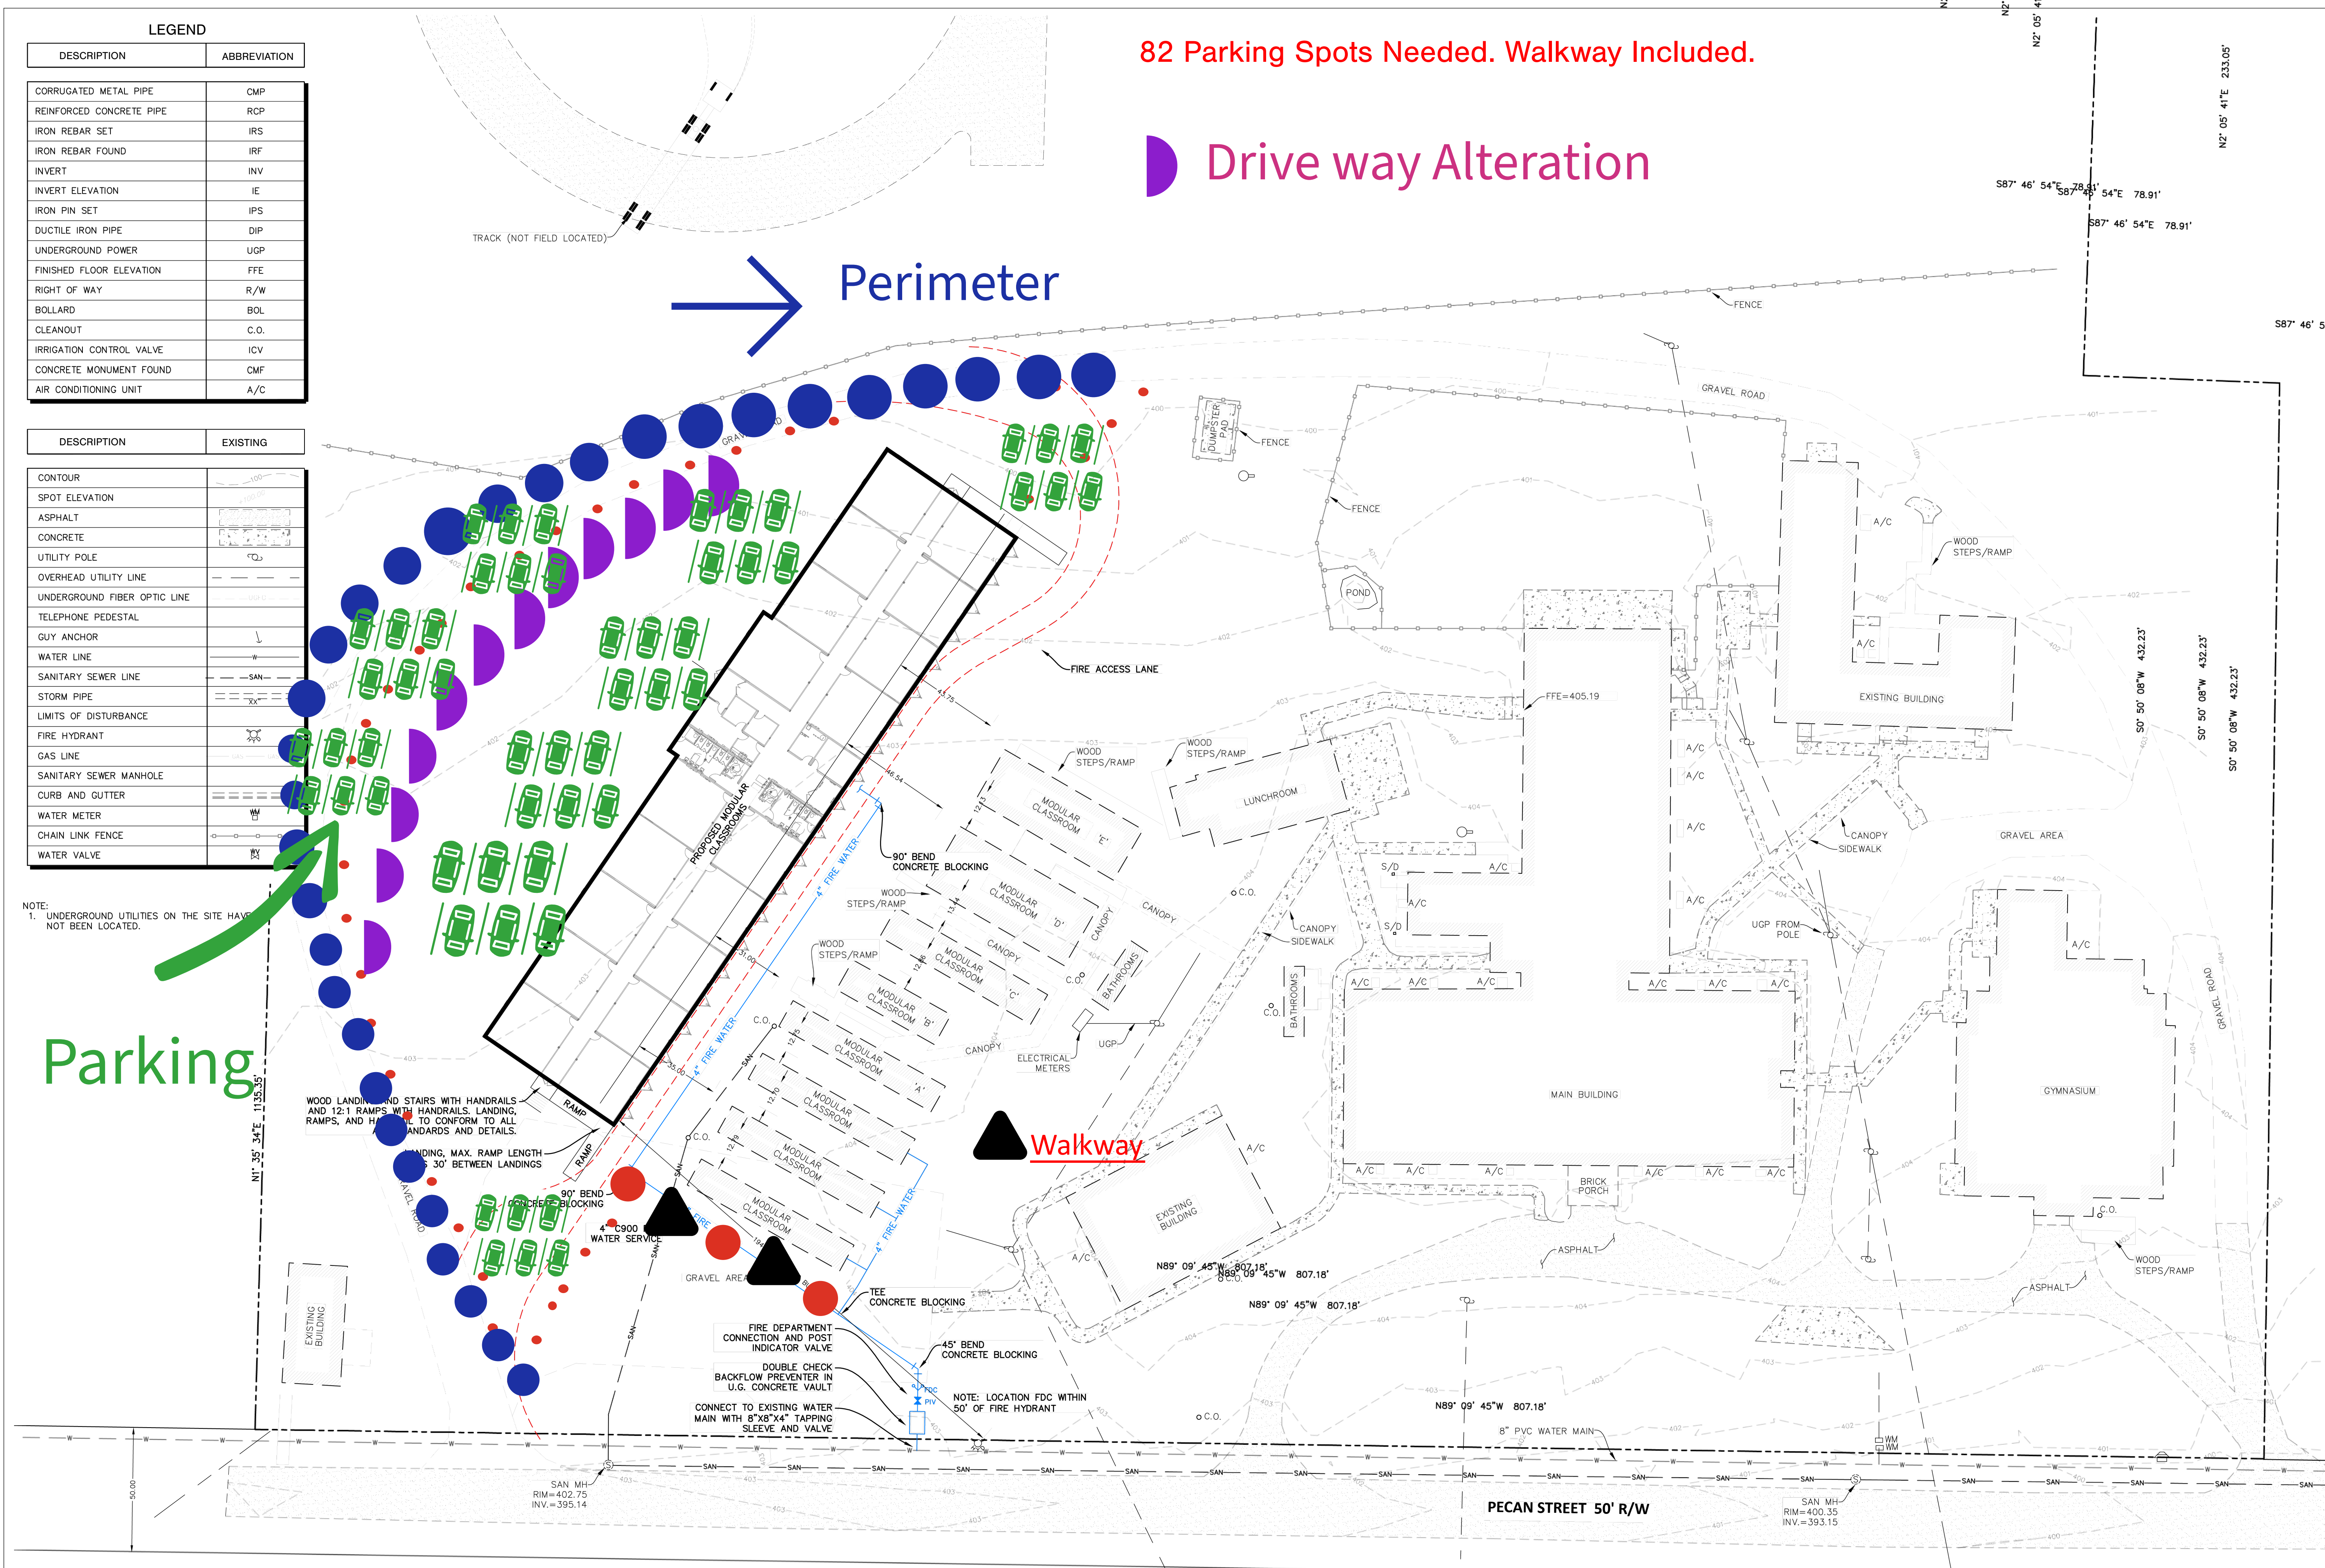

HARRELL JACOBSON
INC.
CIVIL ENGINEERS
P.O. 7290 606 N. CENTRAL AVE., SUITE A TIFTON, GEORGIA 31793 (229) 382-1700
www.harrelljacksoninc.com

LANGFORD ASSOCIATES
INC.
LAND SURVEYORS
P.O. BOX 240 3054 CALHOUN STREET SHELLMAN, GEORGIA 39886 (229) 679-5072
www.langfordandassociates.com

NO.	REVISIONS
1	
2	
3	
4	
5	
6	
7	
8	

PROJECT:
SOWEGA STEM CHARTER SCHOOL
SHELLMAN, RANDOLPH COUNTY, GEORGIA
DATE: SEPTEMBER 1, 2021

JN: 21065
SHEET NUMBER
C1.0
1 OF 1

SITE PLAN

